


- PRIVATE FIRE HYDRANT
- IN / OUT
- BUILDING FOOTPRINT
- PULL HOSE LENGTH



1177 Idaho Street, Suite 200
Redlands, CA 92374
Phone: 909-335-7400
Fax: 909-335-7299
info@miller-aip.com

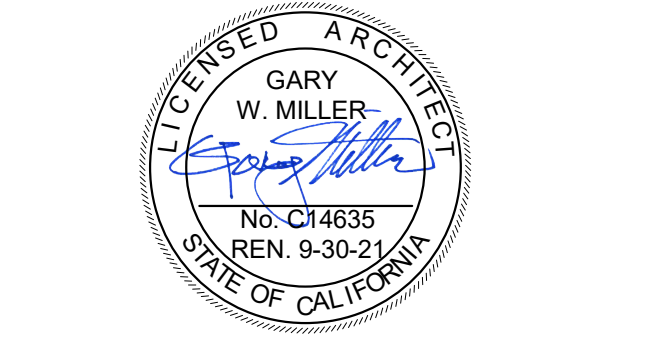

owner approval
initials date phase

revisions/addenda		
#	Date	Comment

THE VENUE - PHASE II
1600 ORANGE AVE
REDLANDS, CALIFORNIA 92373

LUXVIEW PROPERTIES
11230 Sorrento Valley Road, Suite 140, San Diego, CA 92121
theLuxView.com | L@theLuxView.com

project information
Project Number: 2100098.RA
Drawn By: Author
Checked By: GWM
Issue Date: 6/29/23

sheet name
FIRE MASTER
SITE PLAN

sheet number
AS-103

SCALE
1" = 60'-0"